


40'-0"

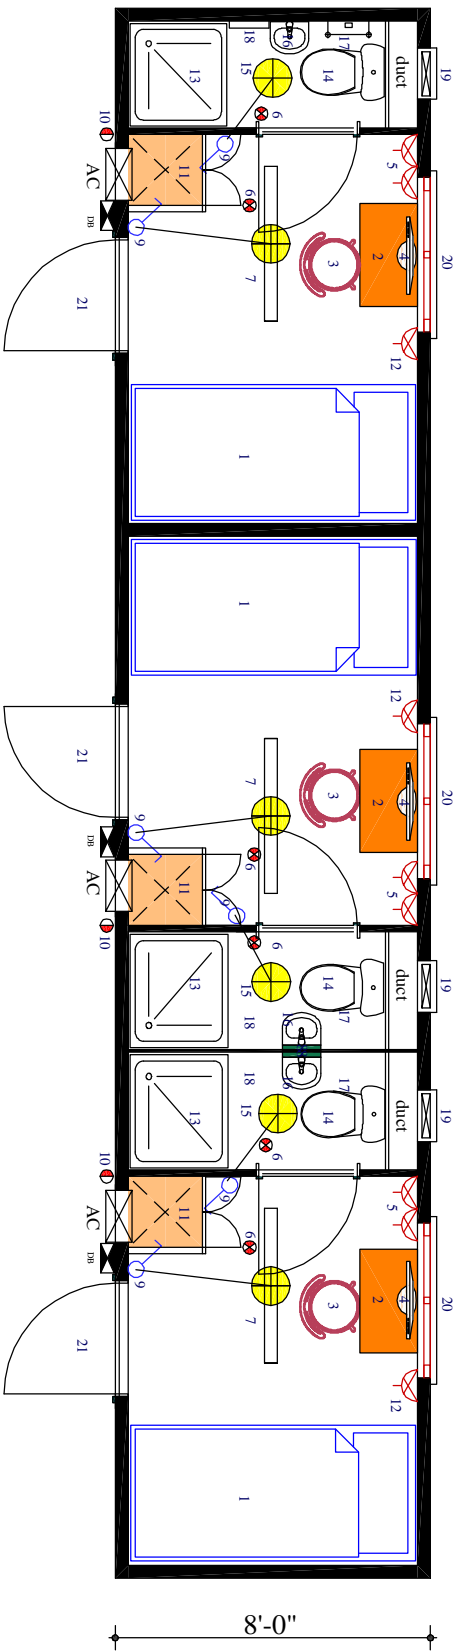

3-MAN ACCOMMODATION FLOOR PLAN

- LEGEND**
1. KING SINGLE BUNKBED / SPRING MATTRESS, PILLOW & 2 DRAWERS
 2. STUDY DESK WITH DRAWERS
 3. CHAIR
 4. T.V
 5. 13 AMPS TWIN SWITCH SOCKET OUTLET
 6. SMOKE DETECTOR
 7. 1200 SINGLE FLOURCENT FTG
 8. MIRROR
 9. SWITCH
 10. PORTABLE EXTINGUISHER
 11. WARDROBE
 12. 5 AMP SINGLE SOCKET OUTLET
 13. SHOWER TRAY
 14. WATER CLOSET
 15. CEILING LIGHT POINT
 16. WASH HAND BASIN
 17. TOILET PAPER HANGER
 18. TOWEL HANGER
 19. EXHAUST FAN
 20. 1200 X 1000mm ALU. SLIDING WINDOW
 21. STEEL INSULATED DOOR WITH GLASS VISION PANEL

GENERAL NOTES:
1. All dimensions in feet unless otherwise indicated.

Drawing to be read in conjunction with drawing No. _____

PLAN

This drawing is property of S.E.C.O. Ltd., it can not be used without authorization.

Southern Engineering Co. Ltd.
 P.O. Box 8000
 Mombasa, Kenya
 TEL: +254 (0) 41 222181/231991/2
 FAX: +254 (0) 41 231909
 E-mail: info@southerneng.co.ke

REV	DATE	BY	CHK'D	APPROVED
1	18.03.08			
2				
3				
4				
5				

CLIENT:	REVISION	DATE	Drawn	Check'd	App'd
PROJECT:					
SITE:					
COUNTRY:					
PROJECT No.:					
DRG. No.:					

CONTAINER CABIN
KENYA

PROJECT No.: SECO/2008/PR00020
 SHEET 1 OF 10